



TRUCK WET UNLOADING STATIONS

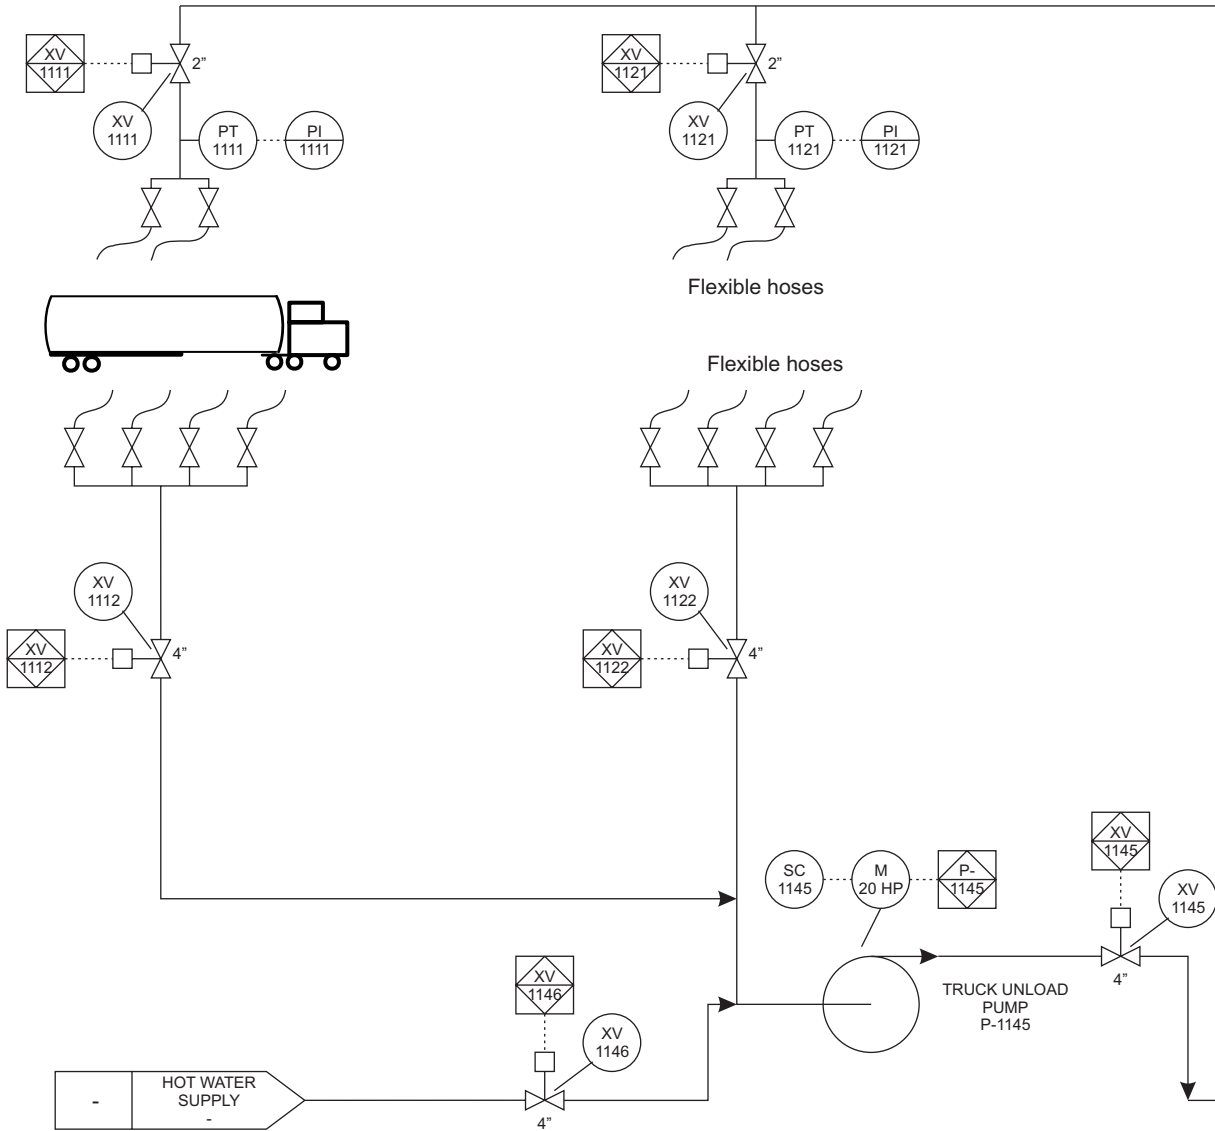

RAILCAR WET UNLOADING STATIONS

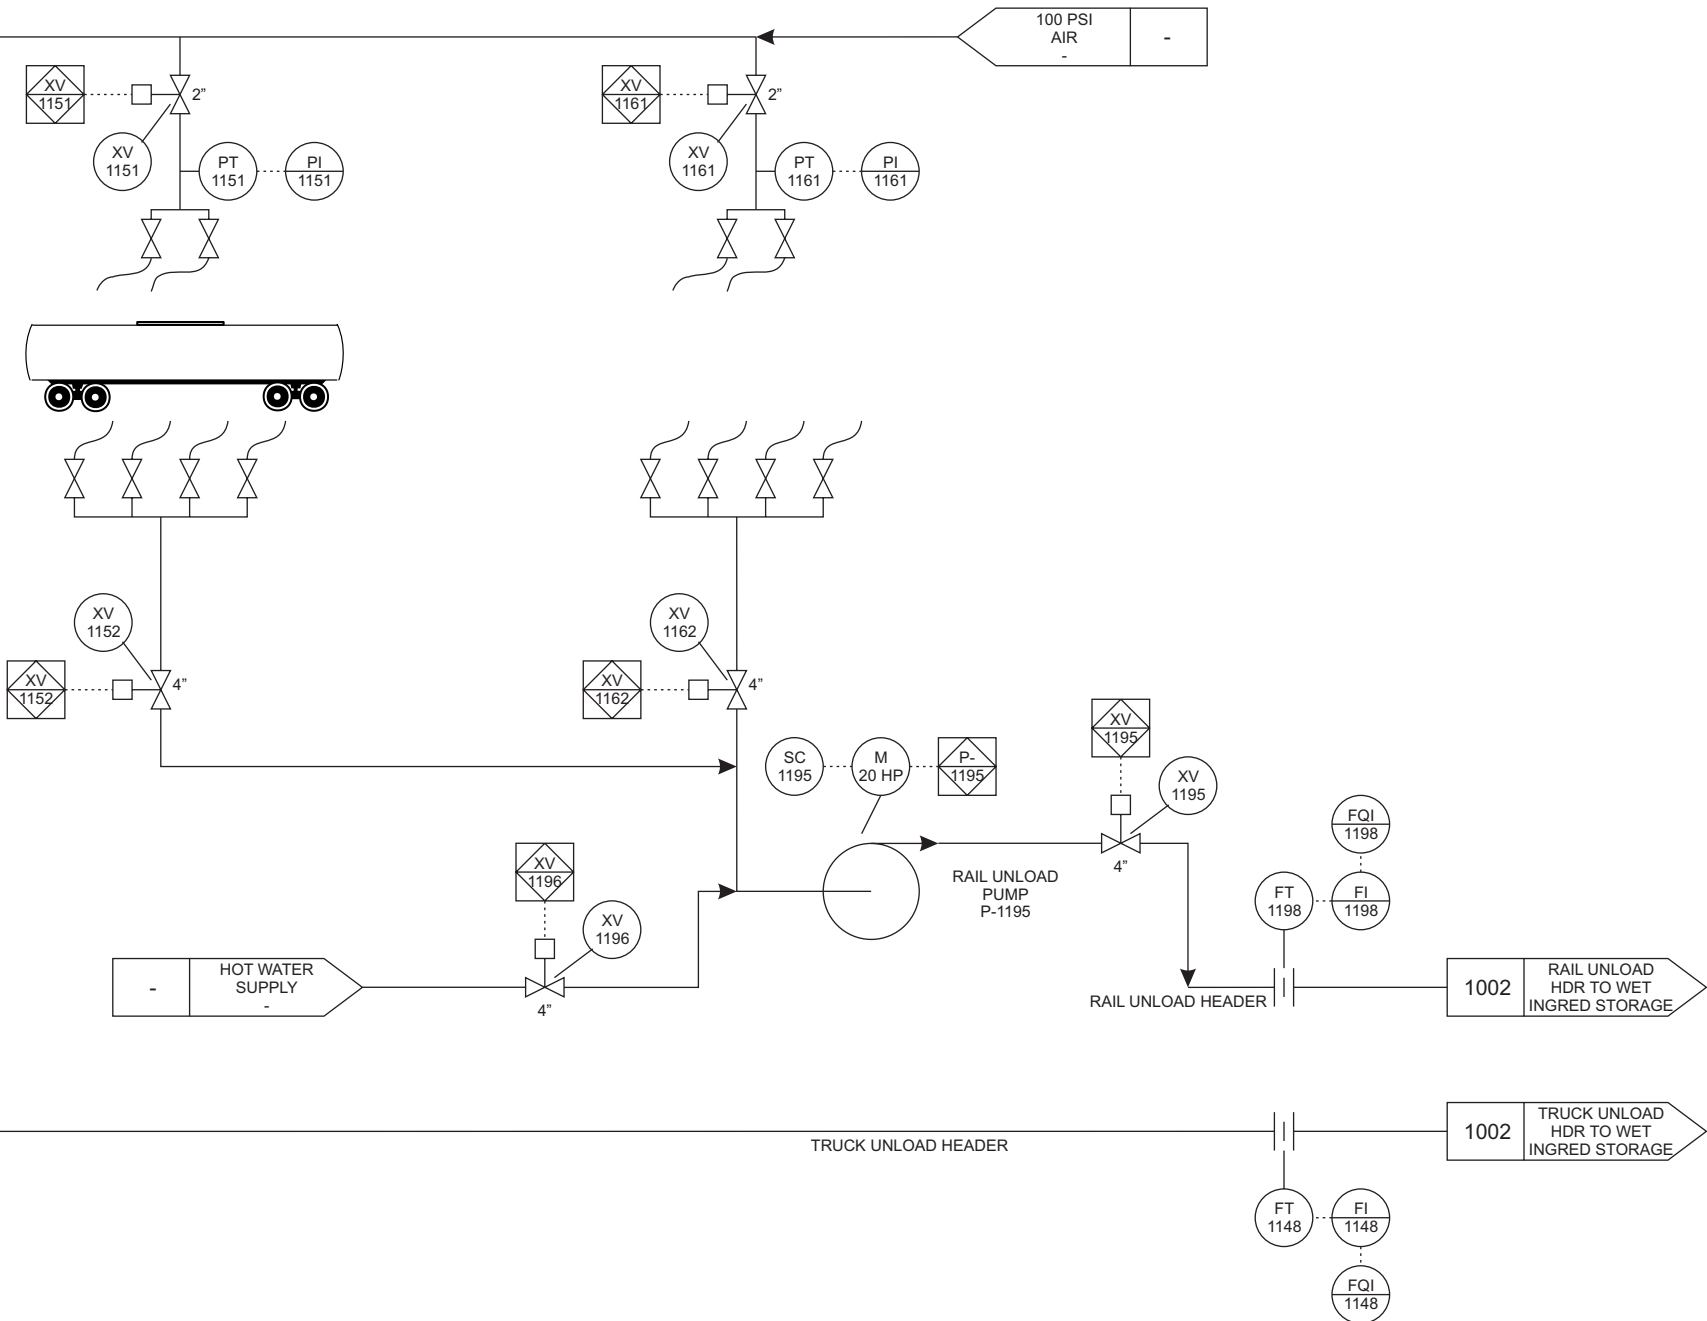

1001

SCALE - NONE	DATE	REV. NO.	DESCRIPTION	DATE	BY	CHKD.	APRD.	REV. NO.	DESCRIPTION	DATE	BY	CHKD.	APRD.
DRAWN BY: KTE	9-22-04	△	HOT WATER USED TO RINSE HEADERS	10-14-04	KTE	CRC	JKS	△	-	-	-	-	-
CHECKED: CRC	9-24-04	△	ADD FLOW ACCUMULATORS	10-20-04	KTE	CRC	JKS	△	-	-	-	-	-
APPROVED: JKS	9-28-04	△	CORRECT OUT STREAM SHEET NUMBERS	9-5-07	KTE	CRC	JKS	△	-	-	-	-	-
APPROVED: JPS	10-01-04	△	-	-	-	-	-	△	-	-	-	-	-

K Process ABC Products	-	AS BUILT	WET UNLOAD 1001 P & ID	CAD REF. NO. 002PD1001
	-	FOR CONSTRUCTION		PROJ. NO. 002
	-	FOR BIDDING ONLY		A. F. E. NO. -
	-	REFERENCE ONLY		DRAWING NO.
DVP Engineering	Anytown, MO	XXX	PRELIMINARY	E-002-PD-1001-3