


TRUCK POWDER UNLOADING STATIONS

RAILCAR POWDER UNLOADING STATIONS

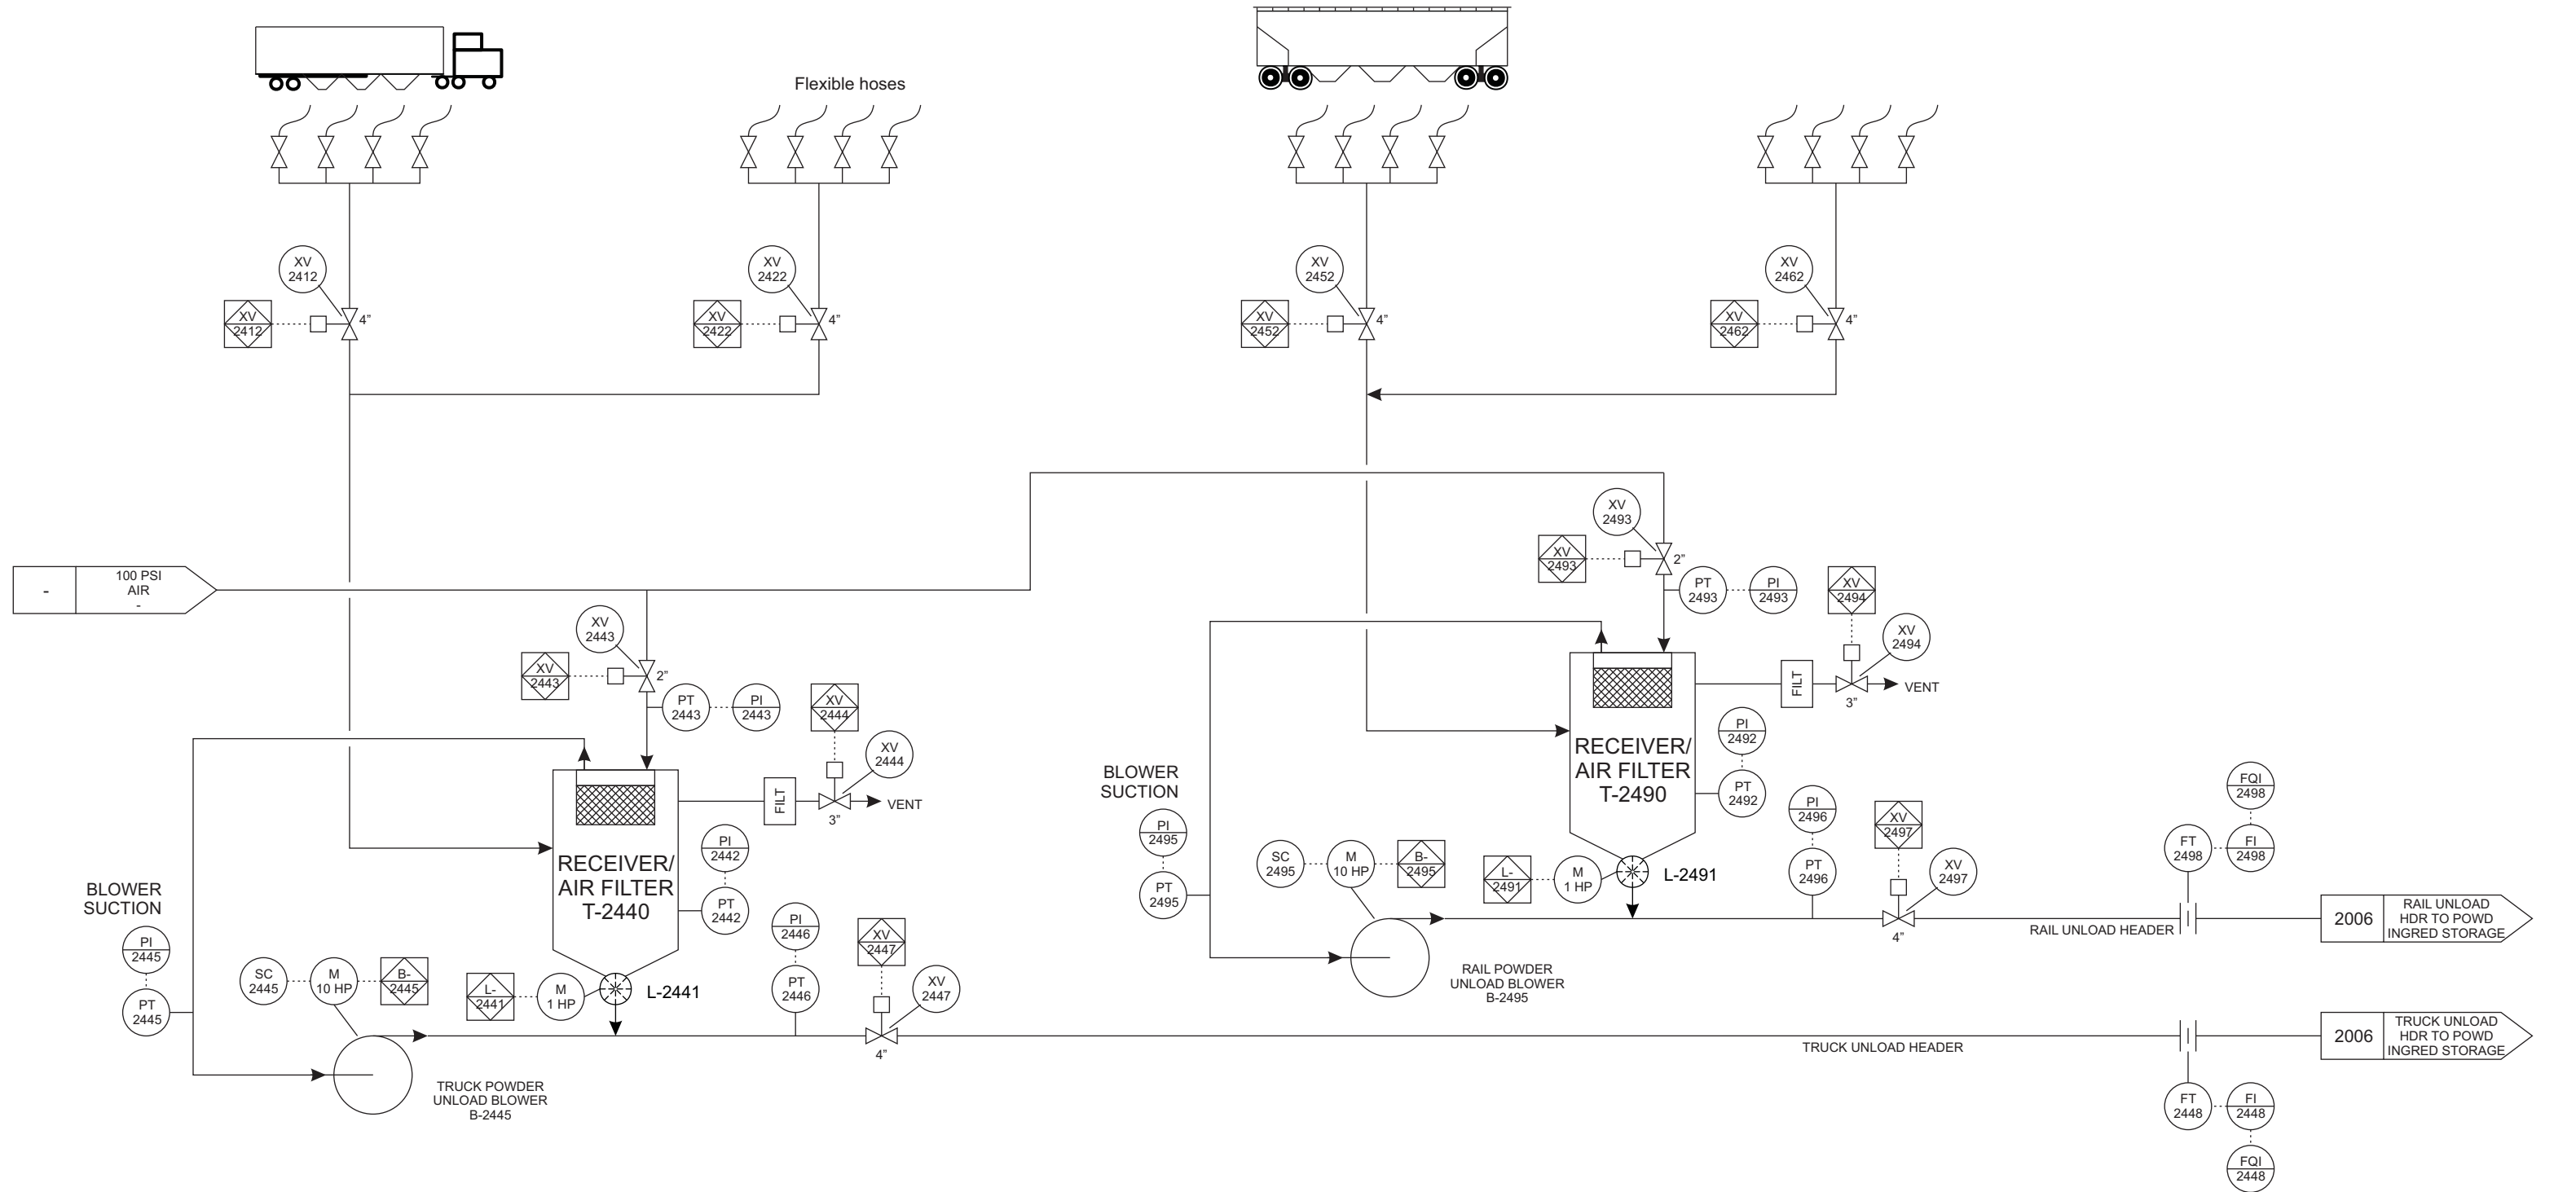

2004

SCALE - NONE	DATE	REV. NO.	DESCRIPTION	DATE	BY	CHKD.	APRD.	REV. NO.	DESCRIPTION	DATE	BY	CHKD.	APRD.
DRAWN BY: KTE	8-25-14	△	-	-	-	-	-	△	-	-	-	-	-
CHECKED: CRC	8-26-14	△	-	-	-	-	-	△	-	-	-	-	-
APPROVED: JKS	8-26-14	△	-	-	-	-	-	△	-	-	-	-	-
APPROVED: JPS	9-02-14	△	-	-	-	-	-	△	-	-	-	-	-

K Process ABC Products	-	AS BUILT
	-	FOR CONSTRUCTION
	-	FOR BIDDING ONLY
	-	REFERENCE ONLY
	XXX	PRELIMINARY
DVP Engineering	Anytown, MO	

POWDER UNLOAD 2004 P & ID	CAD REF. NO. 002PD2004
	PROJ. NO. 002
	A. F. E. NO. -
	DRAWING NO.
	E-002-PD-2004-0